
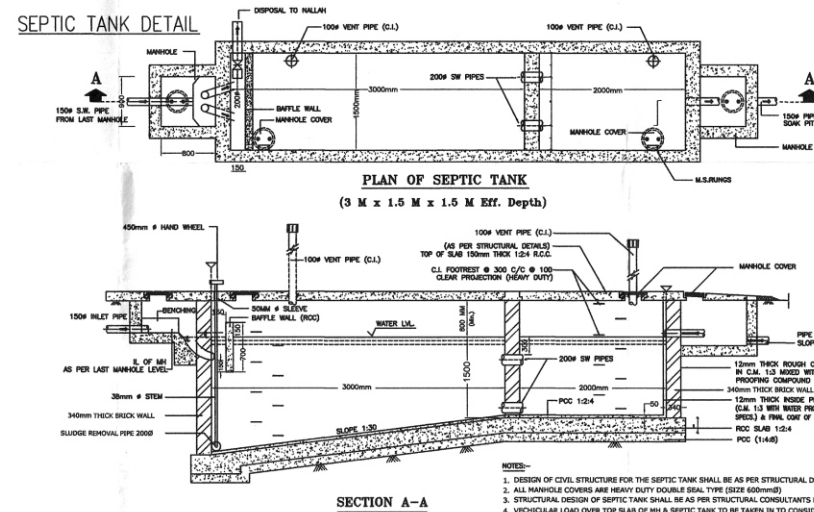
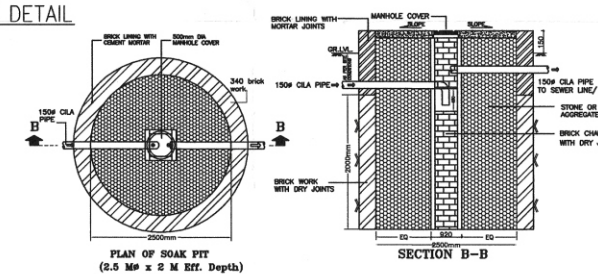
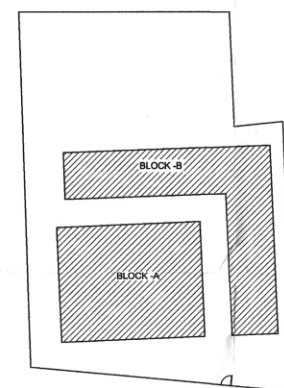
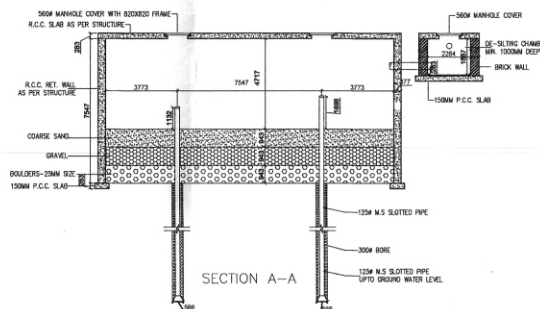
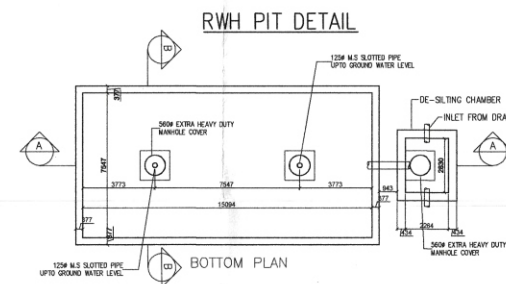
 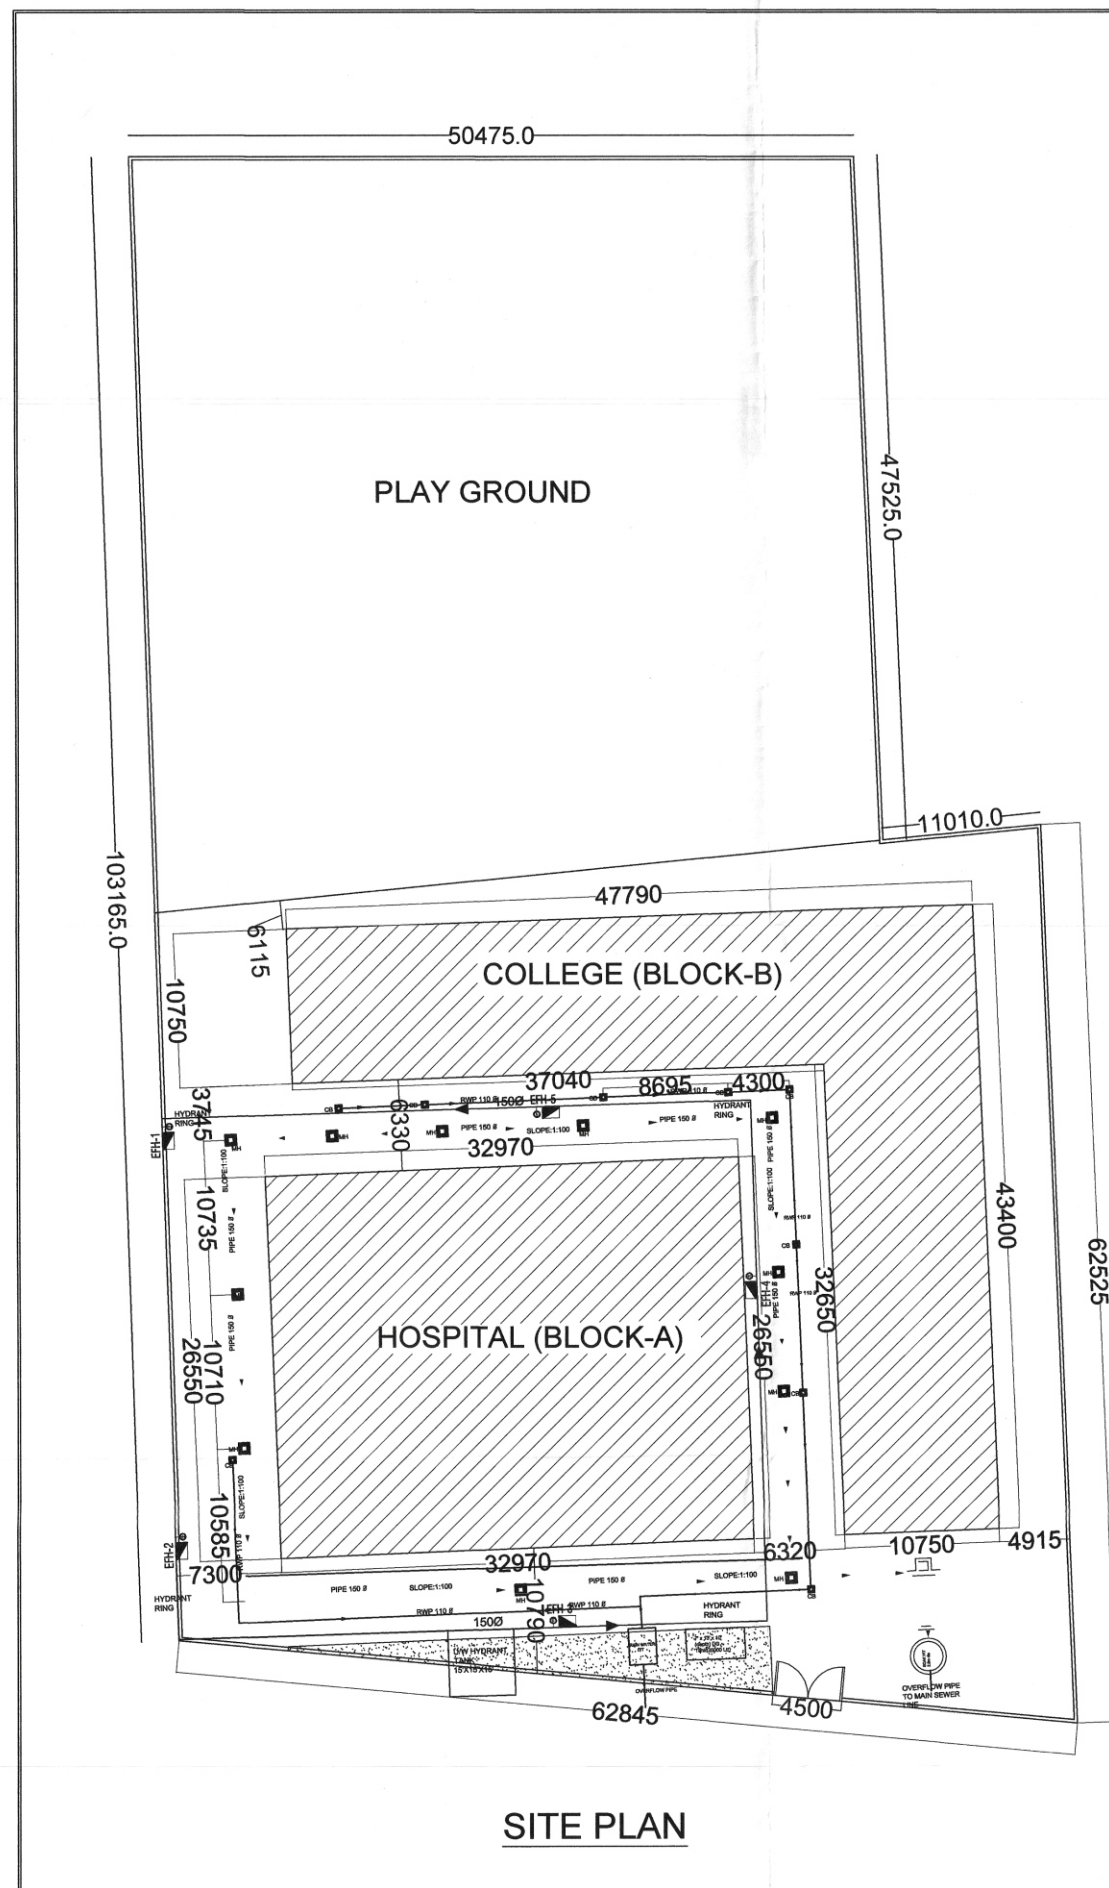




PROJECT TITLE:-
"GYAN SANJIVANI HOSPITAL & INSTITUTE OF
INTERNATIONAL EXCELLENCE (IIE)" SITUATED
AT PLOT NO.- 281-300, VILLAGE DOTAI/KHILWAI'
GARH MEERUT ROAD, TEHSIL GARHMUKTESHWAR
DISTRICT HAPUR (U.P.)

S.N.	LEGEND FOR FIRE
1.	 FIRE EXTINGUISHERS AS PER IS : 2190
2.	 FIRST AID HOSEREEL AS PER IS : 884
3.	 DOWN COMER
4.	 MANUALLY OPERATED ELECTRONIC FIRE ALARM SYSTEM
5.	 TERRACE TANK - 10000+10000 LTR.
6.	 FIRE PUMP - 450+450 LPM
7.	 FHC (HYDRANT VALVE , HOSE REEL, HOSE PIPE, BRANCH PIPE)
8.	 UPRIGHT SPRINKLER
9.	 UNDER GROUND WATER TANK - 10,000 LTR.
10.	 DIESEL PUMP, JOCKY PUMP & ELECTRIC PUMP =1650 LPM SMOKE DETECTOR

S.N.	AREA CHART	SQ.MT.
1.	TOTAL PLOT AREA	6040.00
2.	BLOCK-A COVD. AREA DETAIL	
	PROPOSED COVD. AREA ON G.FL.	838.40
	PROPOSED COVD. AREA ON F.FL.	838.40
	PROPOSED COVD. AREA ON S.FL.	819.90
	TOTAL PROPOSED COVD. AREA ON ALL FLOOR BLOCK - A	2496.70
3.	BLOCK-B COVD. AREA DETAIL	
	PROPOSED COVD. AREA ON G.FL.	896.50
	PROPOSED COVD. AREA ON F.FL.	896.50
	PROPOSED COVD. AREA ON S.FL.	896.50
	TOTAL PROPOSED COVD. AREA ON ALL FLOOR BLOCK - B	2689.50
4.	TOTAL PROPOSED COVD. AREA ON ALL F.	5186.20
5.	PROPOSED GROUND COVERAGE	28.72%
6.	PROPOSED F.A.R.	0.858

GLOBE ARCHITECTURAL POINT 		SITE & KEY PLAN	
		ER. FURQAN ALI GLOBE ARCHITECTURAL POINT 82, "GLOBE HOUSE" OLD BUS STAND MEERUT - BSR. ROAD OPP. THANA KOTWALI TEH. & DISTT. HAPUR OFFICE :-- 0122-2315786 MO.NO. :-- 9837092586, 8791922586	
APPROVED BY:- GRAM PANCHAYAT	SIGN. OF OWNERS 	SIGN. OF ARCHITECTS  A. Mohd. Danish C.O.A Reg. No. CA/2011/19354 P. Arch. Globe Architectural Point 82, Globe House Old Bus Stand Opp. Thana Kotwali Meerut - BSR, Road Hapur (C.D.D) Ballia	
ALL DIMENSION ARE IN METRE	SCALE: 1" = 10'	DATE: 26-07-2023	SHEET NO. 01